



CHAMBLESS | KING
 12 West Jefferson St., Suite 200 | Montgomery, AL 36104
 (334) 252-8238 | chamblessking.com


CONSULTANTS:

Civil
Gonzalez Strength and Associates, Inc.
 2115 Parkway Lane South | Hoover, AL 35244
 Phone: 205.962.2266

Structural
Blackburn Daniels O'Barr
 885 County Road 416 | Loebuck, AL 36752
 Phone: 334.588.0256

Electrical
Consulting Construction Engineering
 2325 Highway 90 South, Suite 101 | Birmingham, AL 35205
 Phone: 205.252.2000

Mechanical & Plumbing
BB&S
 205 Riverchase Business Park, Suite 225 | Birmingham, AL 35242
 Phone: 205.996.6217

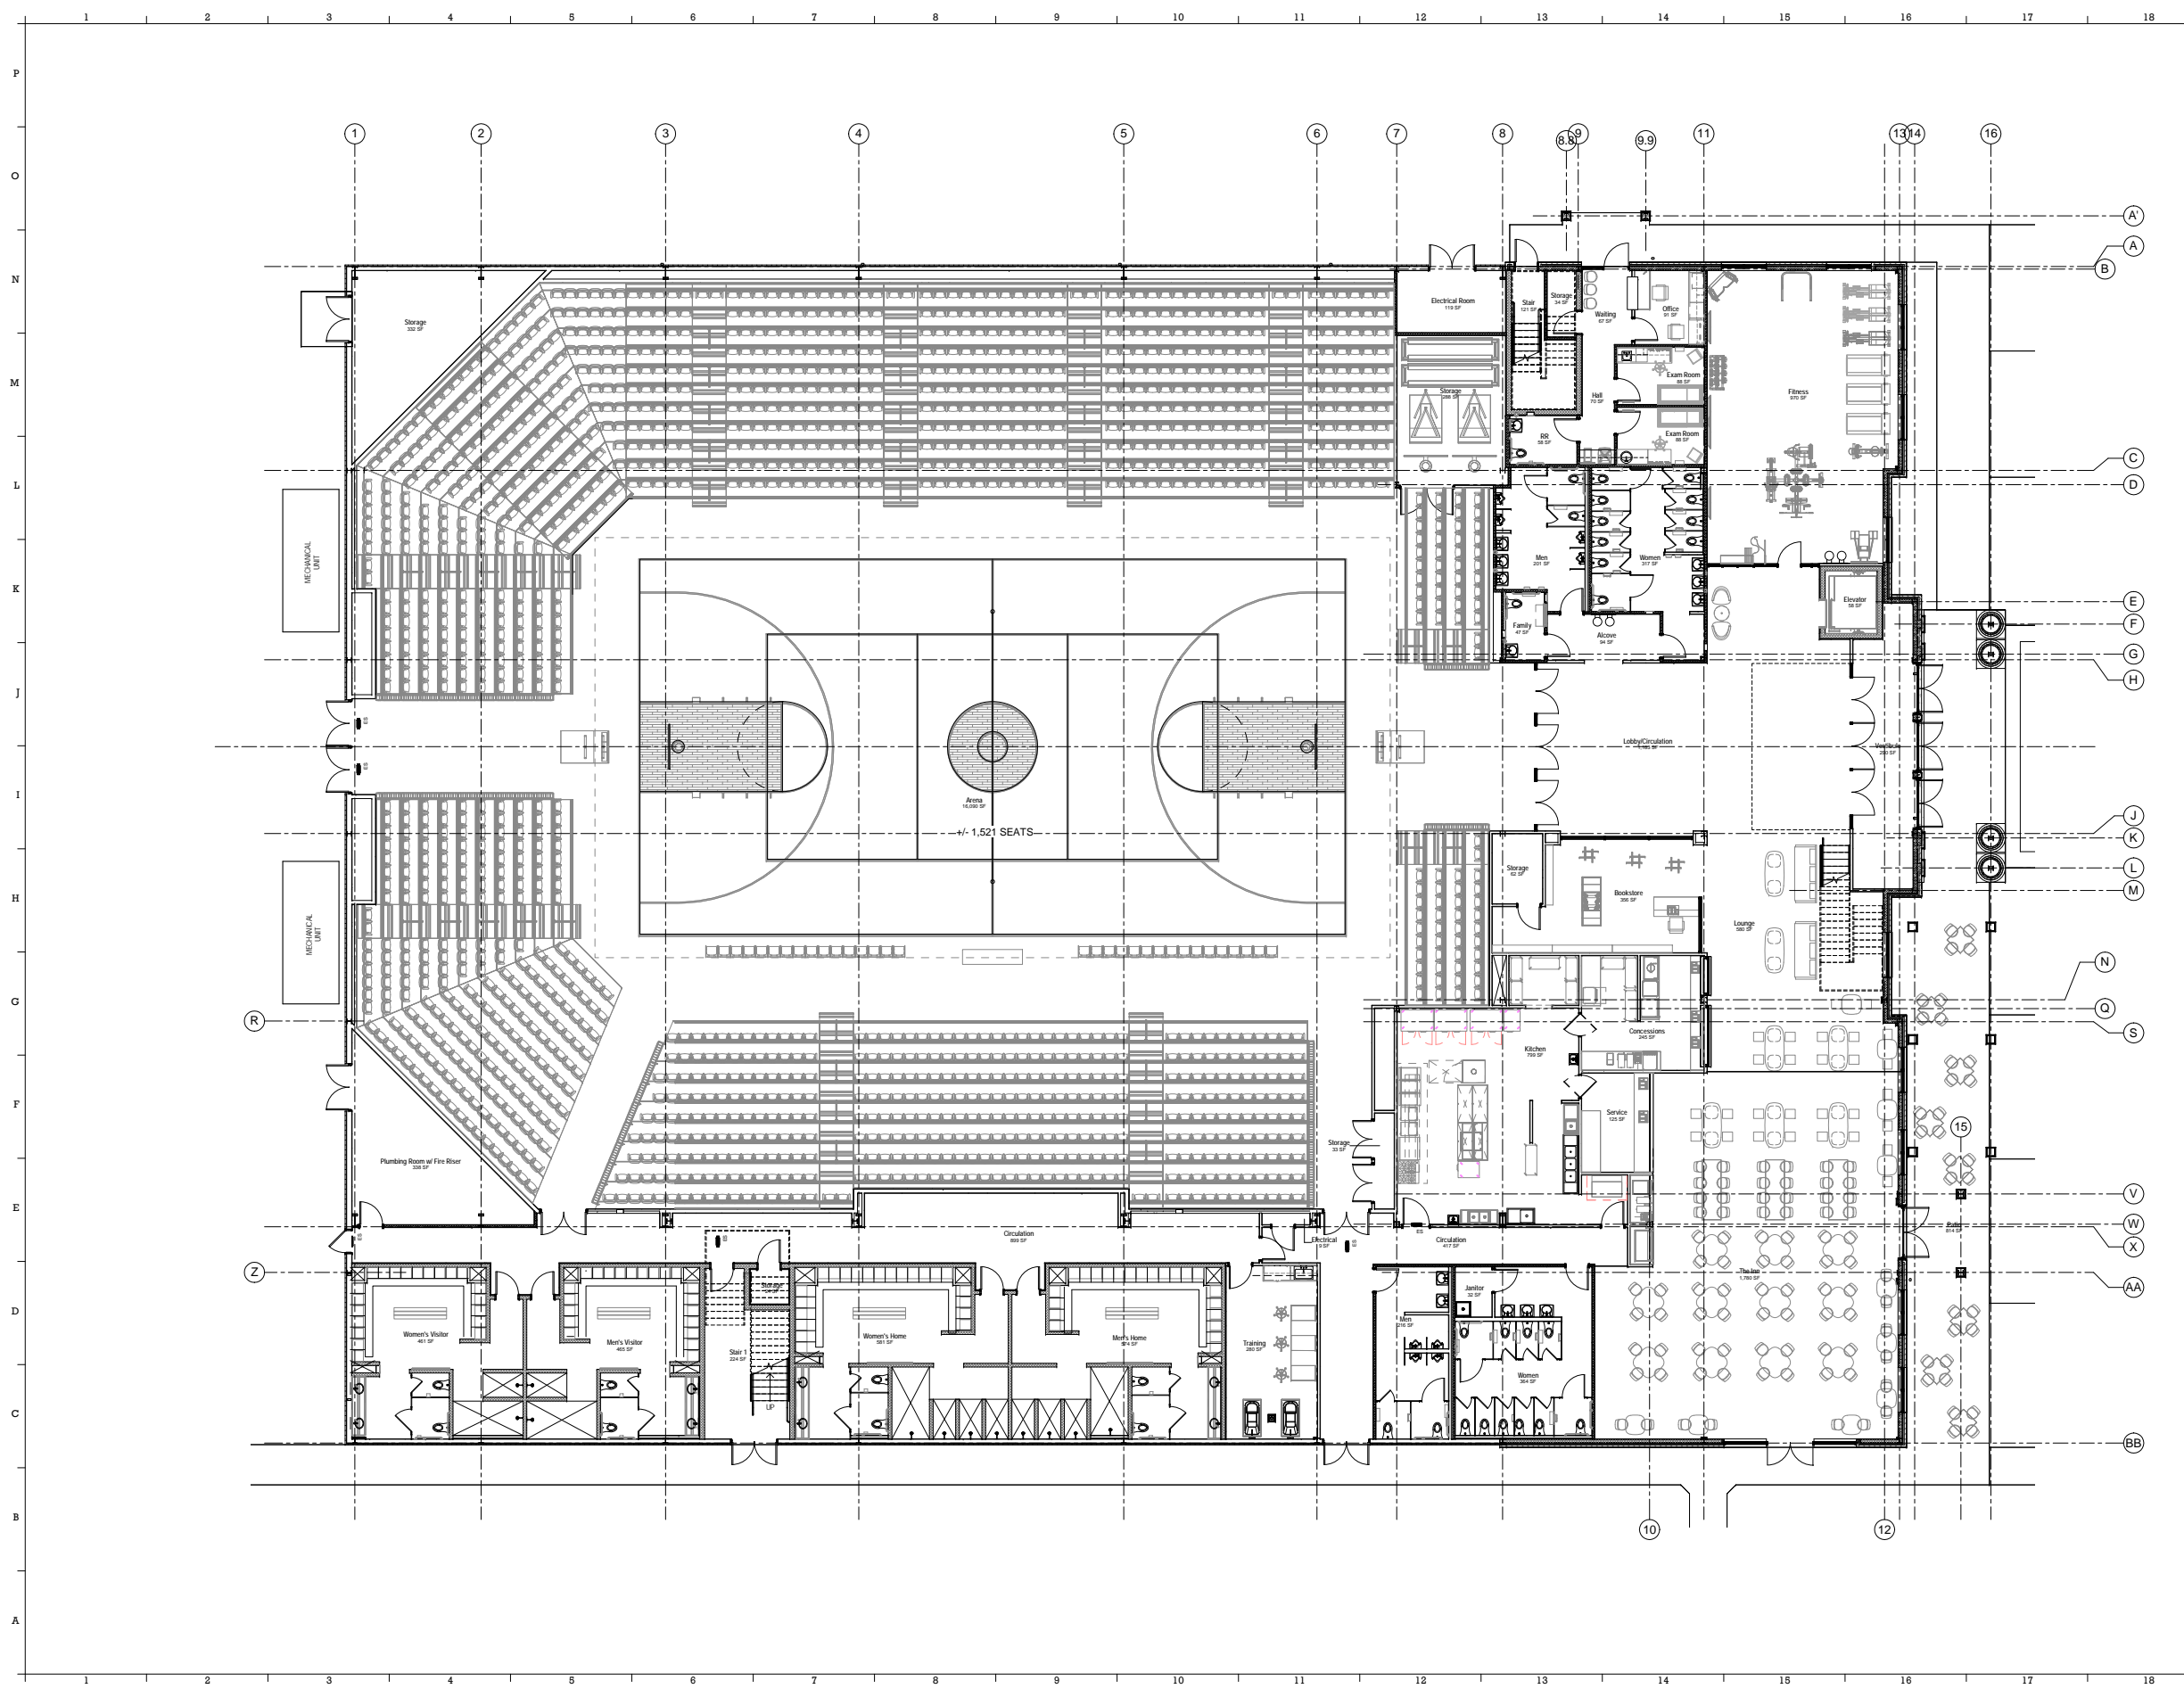

Talladega College
STUDENT CENTER
 10000
 Martin Luther King Drive / Talladega, Alabama 35160

03/26/18

REVISIONS:

SHEET TITLE:
First Floor Plan

SHEET #:
A0001

4/20/2018 9:35:48 AM

